


PM	M	E	P	CAD
RCM	TP	MG	HN	JH/PM/HG

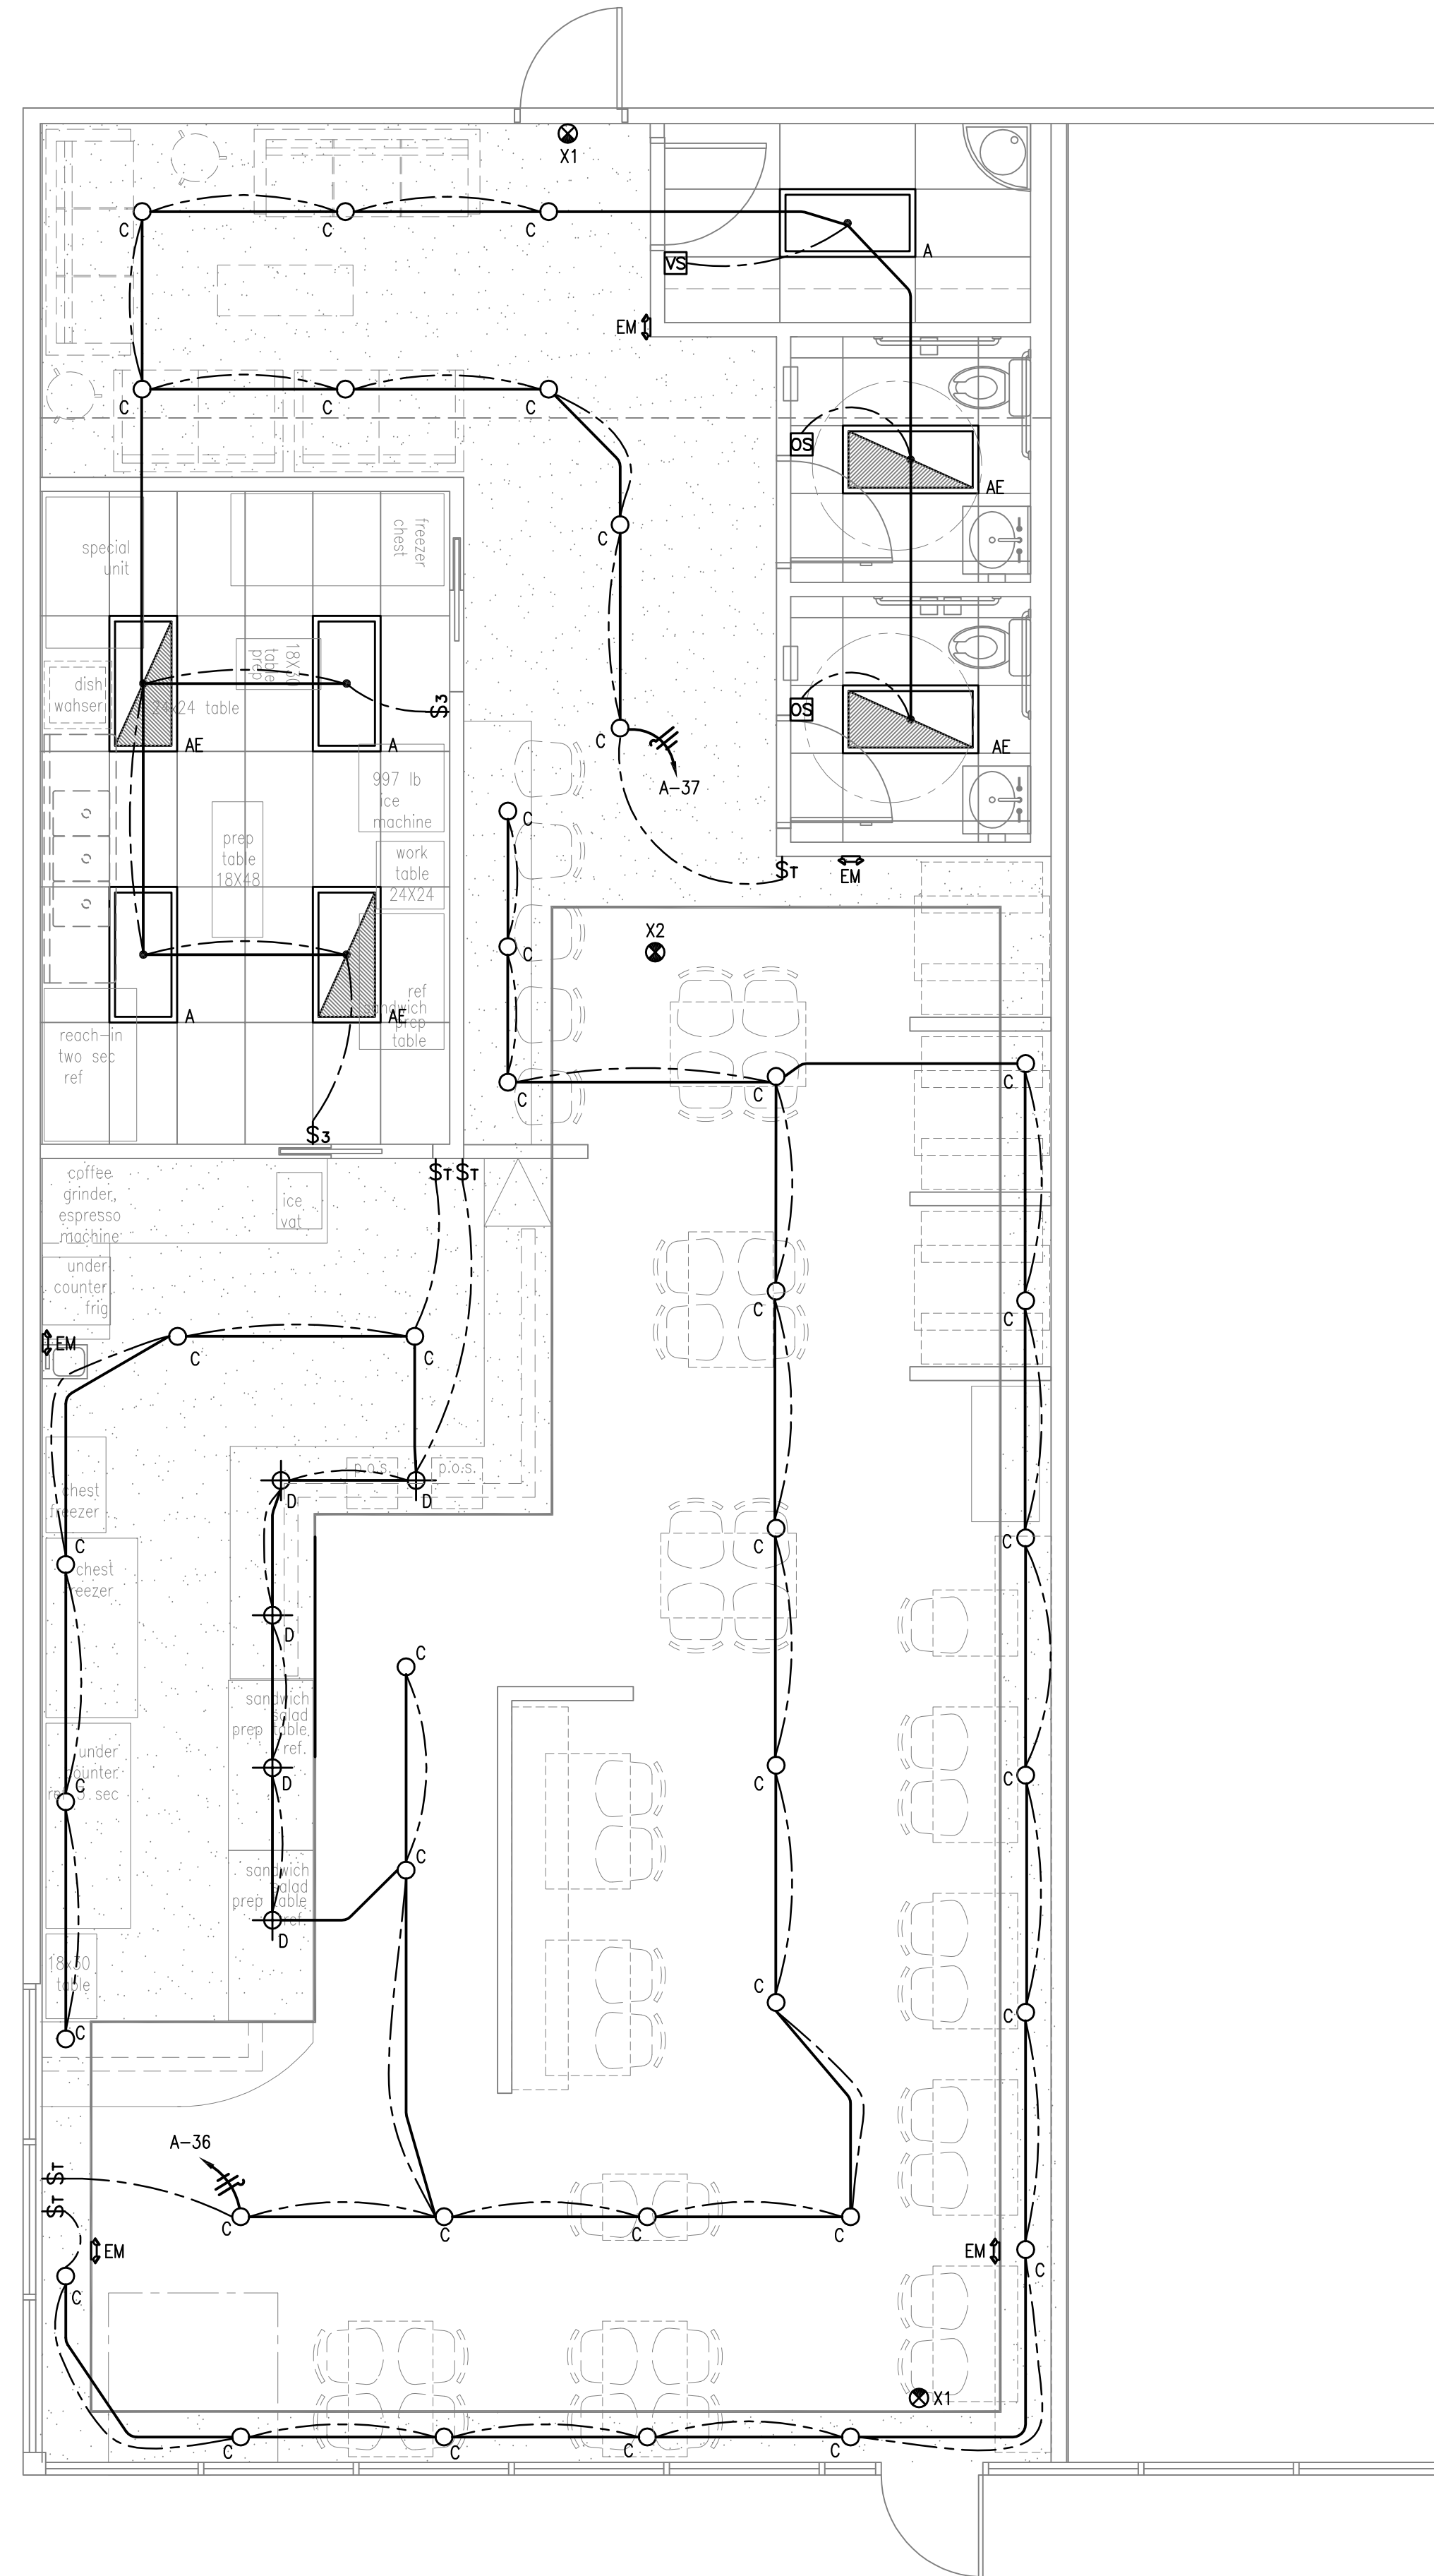

1 ELECTRICAL LIGHTING FLOOR PLAN
SCALE: 1/4" = 1'-0"

LEGEND:

- VS** - VACANCY SENSOR, MANUAL ON 100%, VACANCY SENSOR OFF AFTER 30 MINUTES. HUBBELL #WS OS OR EQUAL.
- OS** - OCCUPANCY SENSOR, FOR FULL-ON UPON ACTIVATION, MANUAL OFF OVERRIDE. HUBBELL #WS OS OR EQUAL.
- \$T** - LEGRAND #RT24W OR EQUAL, PROGRAMMABLE TIMER WITH MANUAL BYPASS (800W RATING).

LIGHTING GENERAL NOTES:

1. SWITCH LOCATIONS SHALL BE VERIFIED BY ARCHITECT PRIOR TO CLOSING OF WALLS.
2. EMERGENCY FIXTURES SHALL HAVE THEIR BALLAST CONNECTED TO UNSWITCHED LIGHTING CIRCUIT.

LIGHTING FIXTURE SCHEDULE- BASE BID

TAG	MANUFACTURER CATALOG NO.	MOUNTING	FIXTURE LAMPS			VOLTAGE	DESCRIPTION	KEYED NOTES	
			QTY	LAMP TYPE	WATTS PER LAMP				INPUT VA
A	LITHONIA #2SP2 G 332 A12125 MVOLT GEB10IS	LAY-IN	3	32WT8	32	90	2 X4 TROFFER, PRISMATIC LENS, A12.125, ELECTRONIC BALLAST		
AE	LITHONIA #2SP2 G 332 A12125 MVOLT GEB10IS EL	LAY-IN	3	32WT8	32	90	MVOLT SAME AS TYPE 'A' BUT WITH EMERGENCY BATTERY PACK		
C	LITHONIA #LDM1 35/10 L06 AR 120	LAY-IN	1	LED	18	18	MVOLT 8" LED DOWNLIGHT		
D	BEGA #L5465	PENDANT	1	LED	20	20	120	LED PENDANT LIGHT FIXTURE	1
EM	LITHONIA #ELM2	WALL	2	MR24	5	12	120 / 277	EMERGENCY EGRESS	1
X1	LITHONIA #LE-S-W-1-R-120/277	WALL/CEILING	1	LED	1	1	120 / 277	SINGLE FACE EXT LIGHT	1,2
X2	LITHONIA #LE-S-W-2-R-120/277	WALL/CEILING	1	LED	1	1	120 / 277	DOUBLE FACE EXT LIGHT	1,2

LIGHTING FIXTURE SCHEDULE KEYED NOTES:

- 1) COORDINATE EXACT MOUNTING HEIGHT WITH ARCHITECT.
- 2) PROVIDE ZERO DEGREE BALLAST.

TEXAS REGISTERED
ENGINEERING FIRM F-10487
700 N. ST. MARY'S
SUITE 1225
SAN ANTONIO, TX 78205
WWW.RGMENGINEERING.NET
PHONE: 210.299.4522
FAX: 210.299.4525

DURAND-HOLLIS RUPE
ARCHITECTS, INC.
14603 HUEBNER RD.
BUILDING 18
SAN ANTONIO,
TEXAS 78230
TEL: 210 308-0080
FAX: 210 697-3309
EMAIL: OFFICE@DHRARCHITECTS.COM

SNOPIOCA
6423 BABCOCK, SUITE 104
SAN ANTONIO, TX 78204

ELECTRICAL LIGHTING FLOOR PLAN

THE SEAL APPEARING ON THIS DOCUMENT WAS AUTHORIZED BY:
ROGER B. MENDEZ, P.E. 93809
ON 04/01/2016



THIS DRAWING IS PROVIDED AS AN INSTRUMENT OF SERVICE BY THE ENGINEER AND IS INTENDED FOR USE ON THIS PROJECT ONLY. THE DRAWING REMAINS THE PROPERTY OF THE ENGINEER AND SHALL BE RETURNED TO HIM/HER UPON COMPLETION OF THE CONSTRUCTION WORK. PURSUANT TO THE ENGINEER WORKS COPYRIGHT PROTECTION ACT OF 1990, ALL DRAWINGS, SPECIFICATIONS, IDEAS AND DESIGNS, INCLUDING THE OVERALL FORM, ARRANGEMENT AND COMPOSITION OF SPACES AND ELEMENTS APPEARING HEREON, CONSTITUTE THE COPYRIGHTED WORK OF THE ENGINEER. ANY REPRODUCTION, USE, OR DISCLOSURE OF INFORMATION CONTAINED HEREIN WITHOUT PRIOR WRITTEN CONSENT OF THE ENGINEER IS STRICTLY PROHIBITED.
© 2015

PROJECT NO. 16-014
ISSUE DATE: 04-01-16
DRAWN BY: RGM
REVIEWED BY: RGM
PROJECT ARCHITECT:
GABRIEL DURAND-HOLLIS, FAIA
TEXAS LICENSE NO. 10881

E101

FILE NAME: 16-000 E101 Electrical Lighting Floor Plan.dwg
OVERALL DATE: 04/01/2016
DATE: Thu, 31 Mar 2016 11:51:37am
PLOTTER: HP
PLOTTER: HP