


1 ELECTRICAL POWER FLOOR PLAN
SCALE: 1/4" = 1'-0"

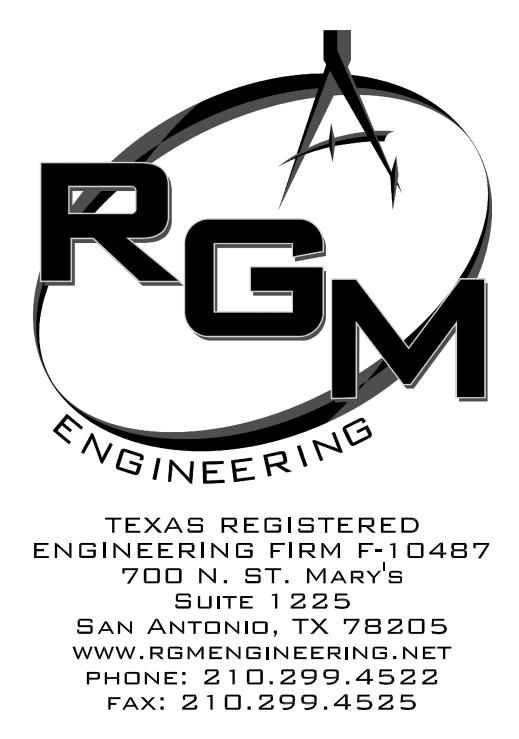

DHR ARCHITECTS
DURAND-HOLLIS RUPE ARCHITECTS, INC.
14603 HUEBNER RD.
BUILDING 18
SAN ANTONIO, TEXAS 78230
TEL: 210 308-0080
FAX: 210 697-3309
eMAIL: OFFICE@DHRARCHITECTS.COM

KITCHEN EQUIPMENT SCHEDULE										
ELECTRICAL CONNECTION										
ITEM NO.	QTY	DESCRIPTION	ELECTRICAL					KEYED NOTES		
			VOLTI/PH	CYCLE	AMPS / VA / HP	CONDUIT / CONDUCTORS	CIRCUIT NUMBER	DIRECT CONNECTION	NEMA TYPE RECEPTACLE	MTG HT.
E	1	ICE VAT								
N	1	UNDERCOUNTER REFRIGERATOR	120V/1ϕ	60 Hz	14.2A	2#12, 1#12G-12"C.		NO	5-20P	24"
O	1	REFRIGERATED DISPLAY CASE, 43 CU FT	120V/1ϕ	60 Hz	15.5A, 1860VA	2#12, 1#12G-12"C.		NO	5-20P	24"
Q	1	ICE MACHINE, 500 LB	120V/1ϕ	60 Hz	17.1A	2#12, 1#12G-12"C.		NO	5-20P	44"
R	1	CHEST FREEZER	120V/1ϕ	60 Hz	10A					
S	2	CHEST FREEZER	120V/1ϕ	60 Hz	14A					
U	1	COUNTER FRIDGE, 2 DOOR	120V/1ϕ	60 Hz	7A, 1/2HP	2#12, 1#12G-12"C.		NO	5-20P	24"
V	1	SALAD PREP TABLE	120V/1ϕ	60 Hz	7A, 1/2HP	2#12, 1#12G-12"C.		NO	5-20P	24"
W		COFFE GRINDER								
X		EXPRESSO MACHINE	120V/1ϕ	60 Hz	12A	2#12, 1#12G-12"C.		NO	5-20P	24"
Y		COFFEE MAKER	208V/1ϕ	60 Hz	29A	2#8, #2GND 1"C		NO		24"
Z	1	DISH WASHER								

NOTE: ALL EQUIPMENT CONNECTION REQUIREMENTS TO BE COORDINATED WITH FINAL EQUIPMENT IN FIELD.

- ELECTRICAL KEYED NOTES:**
- ① COORDINATE PANEL LOCATION WITH ARCHITECT PRIOR TO ROUGH-IN WORK.
 - ② CONNECT TO LIGHTING CIRCUIT.
 - ③ 30A/NF/2P/N3R ON RACK
 - ④ 100A/NF/3P/N3R ON RACK

- ELECTRICAL GENERAL NOTES:**
- 1. COORDINATE KITCHEN EQUIPMENT REQUIREMENTS WITH KITCHEN EQUIPMENT SUPPLIER.

SNOPIOCA
6423 BABCOCK, SUITE 104
SAN ANTONIO, TX 78204

ELECTRICAL POWER FLOOR PLAN

THE SEAL APPEARING ON THIS DOCUMENT WAS AUTHORIZED BY:
ROGER B. MENDEZ, P.E. 93809
ON 04/01, 2016



THIS DRAWING IS PROVIDED AS AN INSTRUMENT OF SERVICE BY THE ENGINEER AND IS INTENDED FOR USE ON THIS PROJECT ONLY. THE DRAWING REMAINS THE PROPERTY OF THE ENGINEER AND SHALL BE RETURNED TO HIM/HER UPON COMPLETION OF THE CONSTRUCTION WORK. PURSUANT TO THE ENGINEER WORKS COPYRIGHT PROTECTION ACT OF 1990, ALL DRAWINGS, SPECIFICATIONS, IDEAS AND DESIGNS, INCLUDING THE OVERALL FORM, ARRANGEMENT AND COMPOSITION OF SPACES AND ELEMENTS APPEARING HEREON, CONSTITUTES THE COPYRIGHTED WORK OF THE ENGINEER. ANY REPRODUCTION, USE, OR DISCLOSURE OF INFORMATION CONTAINED HEREIN WITHOUT PRIOR WRITTEN CONSENT OF THE ENGINEER IS STRICTLY PROHIBITED.
© 2015

PROJECT NO. 16-014
ISSUE DATE: 04-01-16
DRAWN BY: RGM
REVIEWED BY: RGM
PROJECT ARCHITECT:
GABRIEL DURAND-HOLLIS, FAIA
TEXAS LICENSE NO. 10881

E102